




INTERNATIONAL ASSOCIATION OF  
**Forensic Nurses**

**FORENSIC NURSING SCIENCE AND PRACTICE  
FAIRMONT ROYAL YORK - CONCERT HALL AND FOYER  
OCTOBER 11<sup>TH</sup>-14<sup>TH</sup>, 2017**

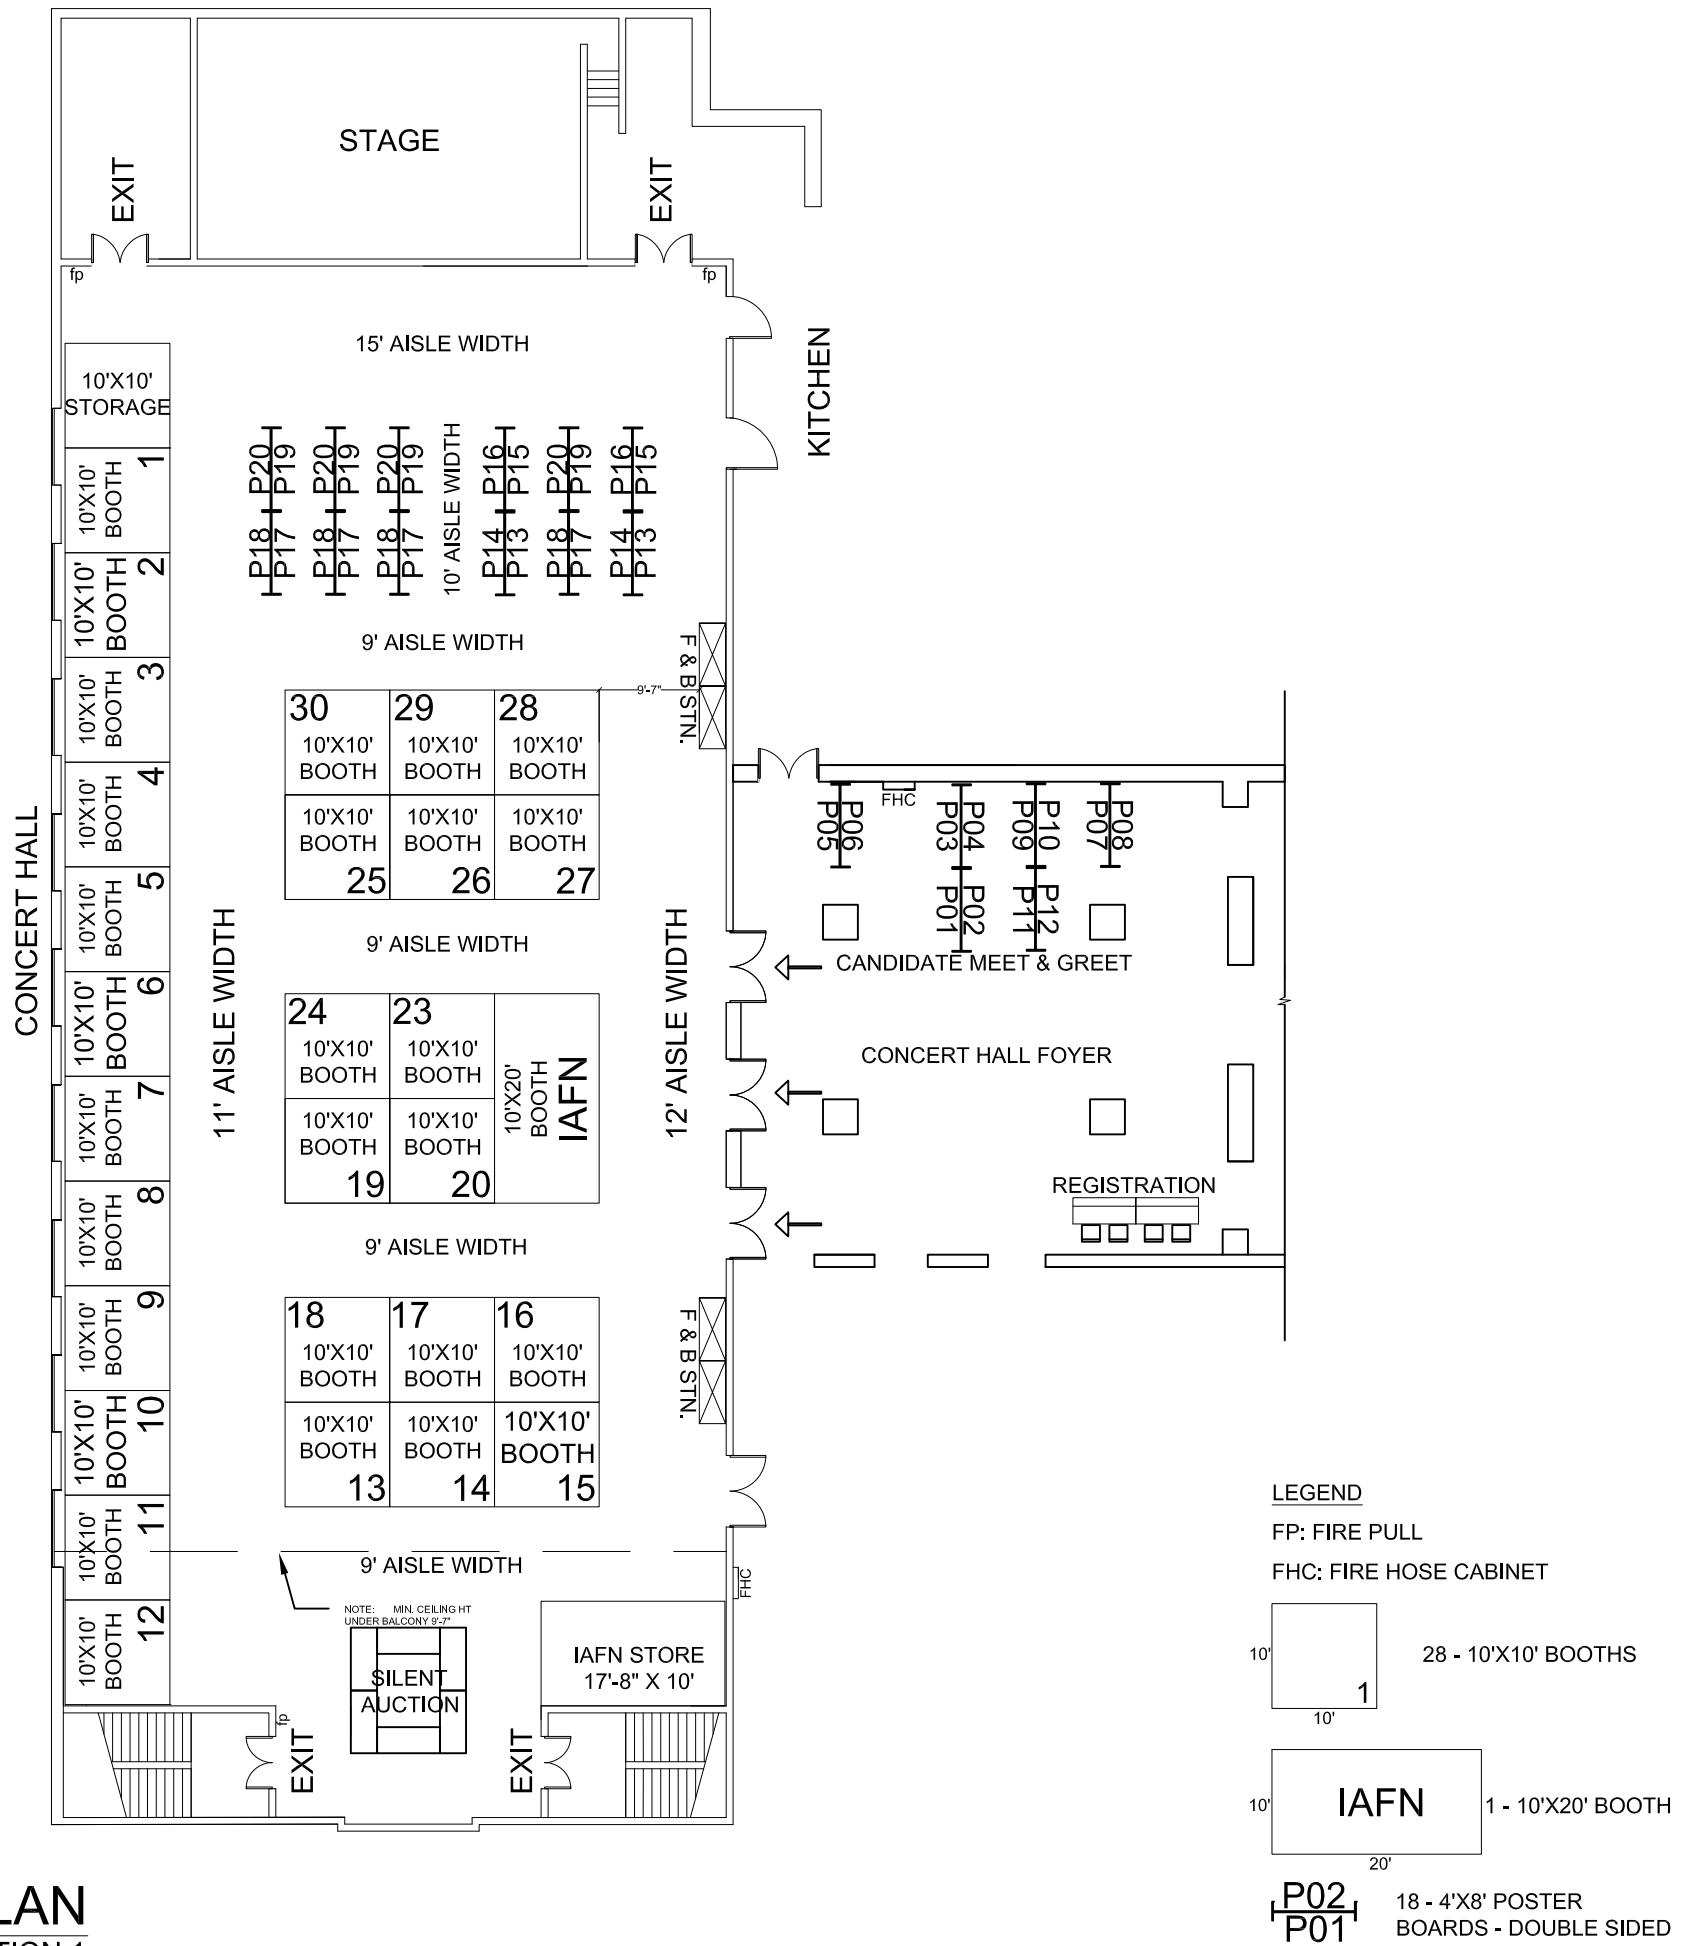

**PLAN  
OPTION 1**

**LEGEND**  
 FP: FIRE PULL  
 FHC: FIRE HOSE CABINET

10' 10' 28 - 10'X10' BOOTHS

10' 20' IAFN 1 - 10'X20' BOOTH

P02 P01 18 - 4'X8' POSTER BOARDS - DOUBLE SIDED



**SHOW:**  
2017 INTERNATIONAL CONFERENCE ON FORENSIC NURSING SCIENCE AND PRACTICE

**SHOW DATE:**  
OCTOBER 11<sup>TH</sup> - 14<sup>TH</sup>, 2017

**SHOW FLOOR:** CONCERT HALL & FOYER:  
28 - 10' X 10' & 1 - 10'X20' IAFN BOOTH, 18 - 4'X8' POSTER BOARDS, SILENT AUCTION/STORE & REGISTRATION.

**SCALE**



**NOTE:** FLOOR PLAN MUST BE APPROVED BY FIRE MARSHAL AND/OR FACILITY / VENUE PRIOR TO EVENT DATE.

© COPYRIGHT 2017 THIS PLAN/DESIGN REMAINS THE EXCLUSIVE PROPERTY OF ROBINSON SHOW SERVICES INC., AND SHOULD NOT BE REPRODUCED WITHOUT WRITTEN PERMISSION AND/OR CONSENT.

PLAN DATE: JULY 12<sup>TH</sup>, 2016  
REV#3: FEBRUARY 28<sup>TH</sup>, 2017

DRAWN BY: R. ORAHA

**DRAWING NO.:** 02